

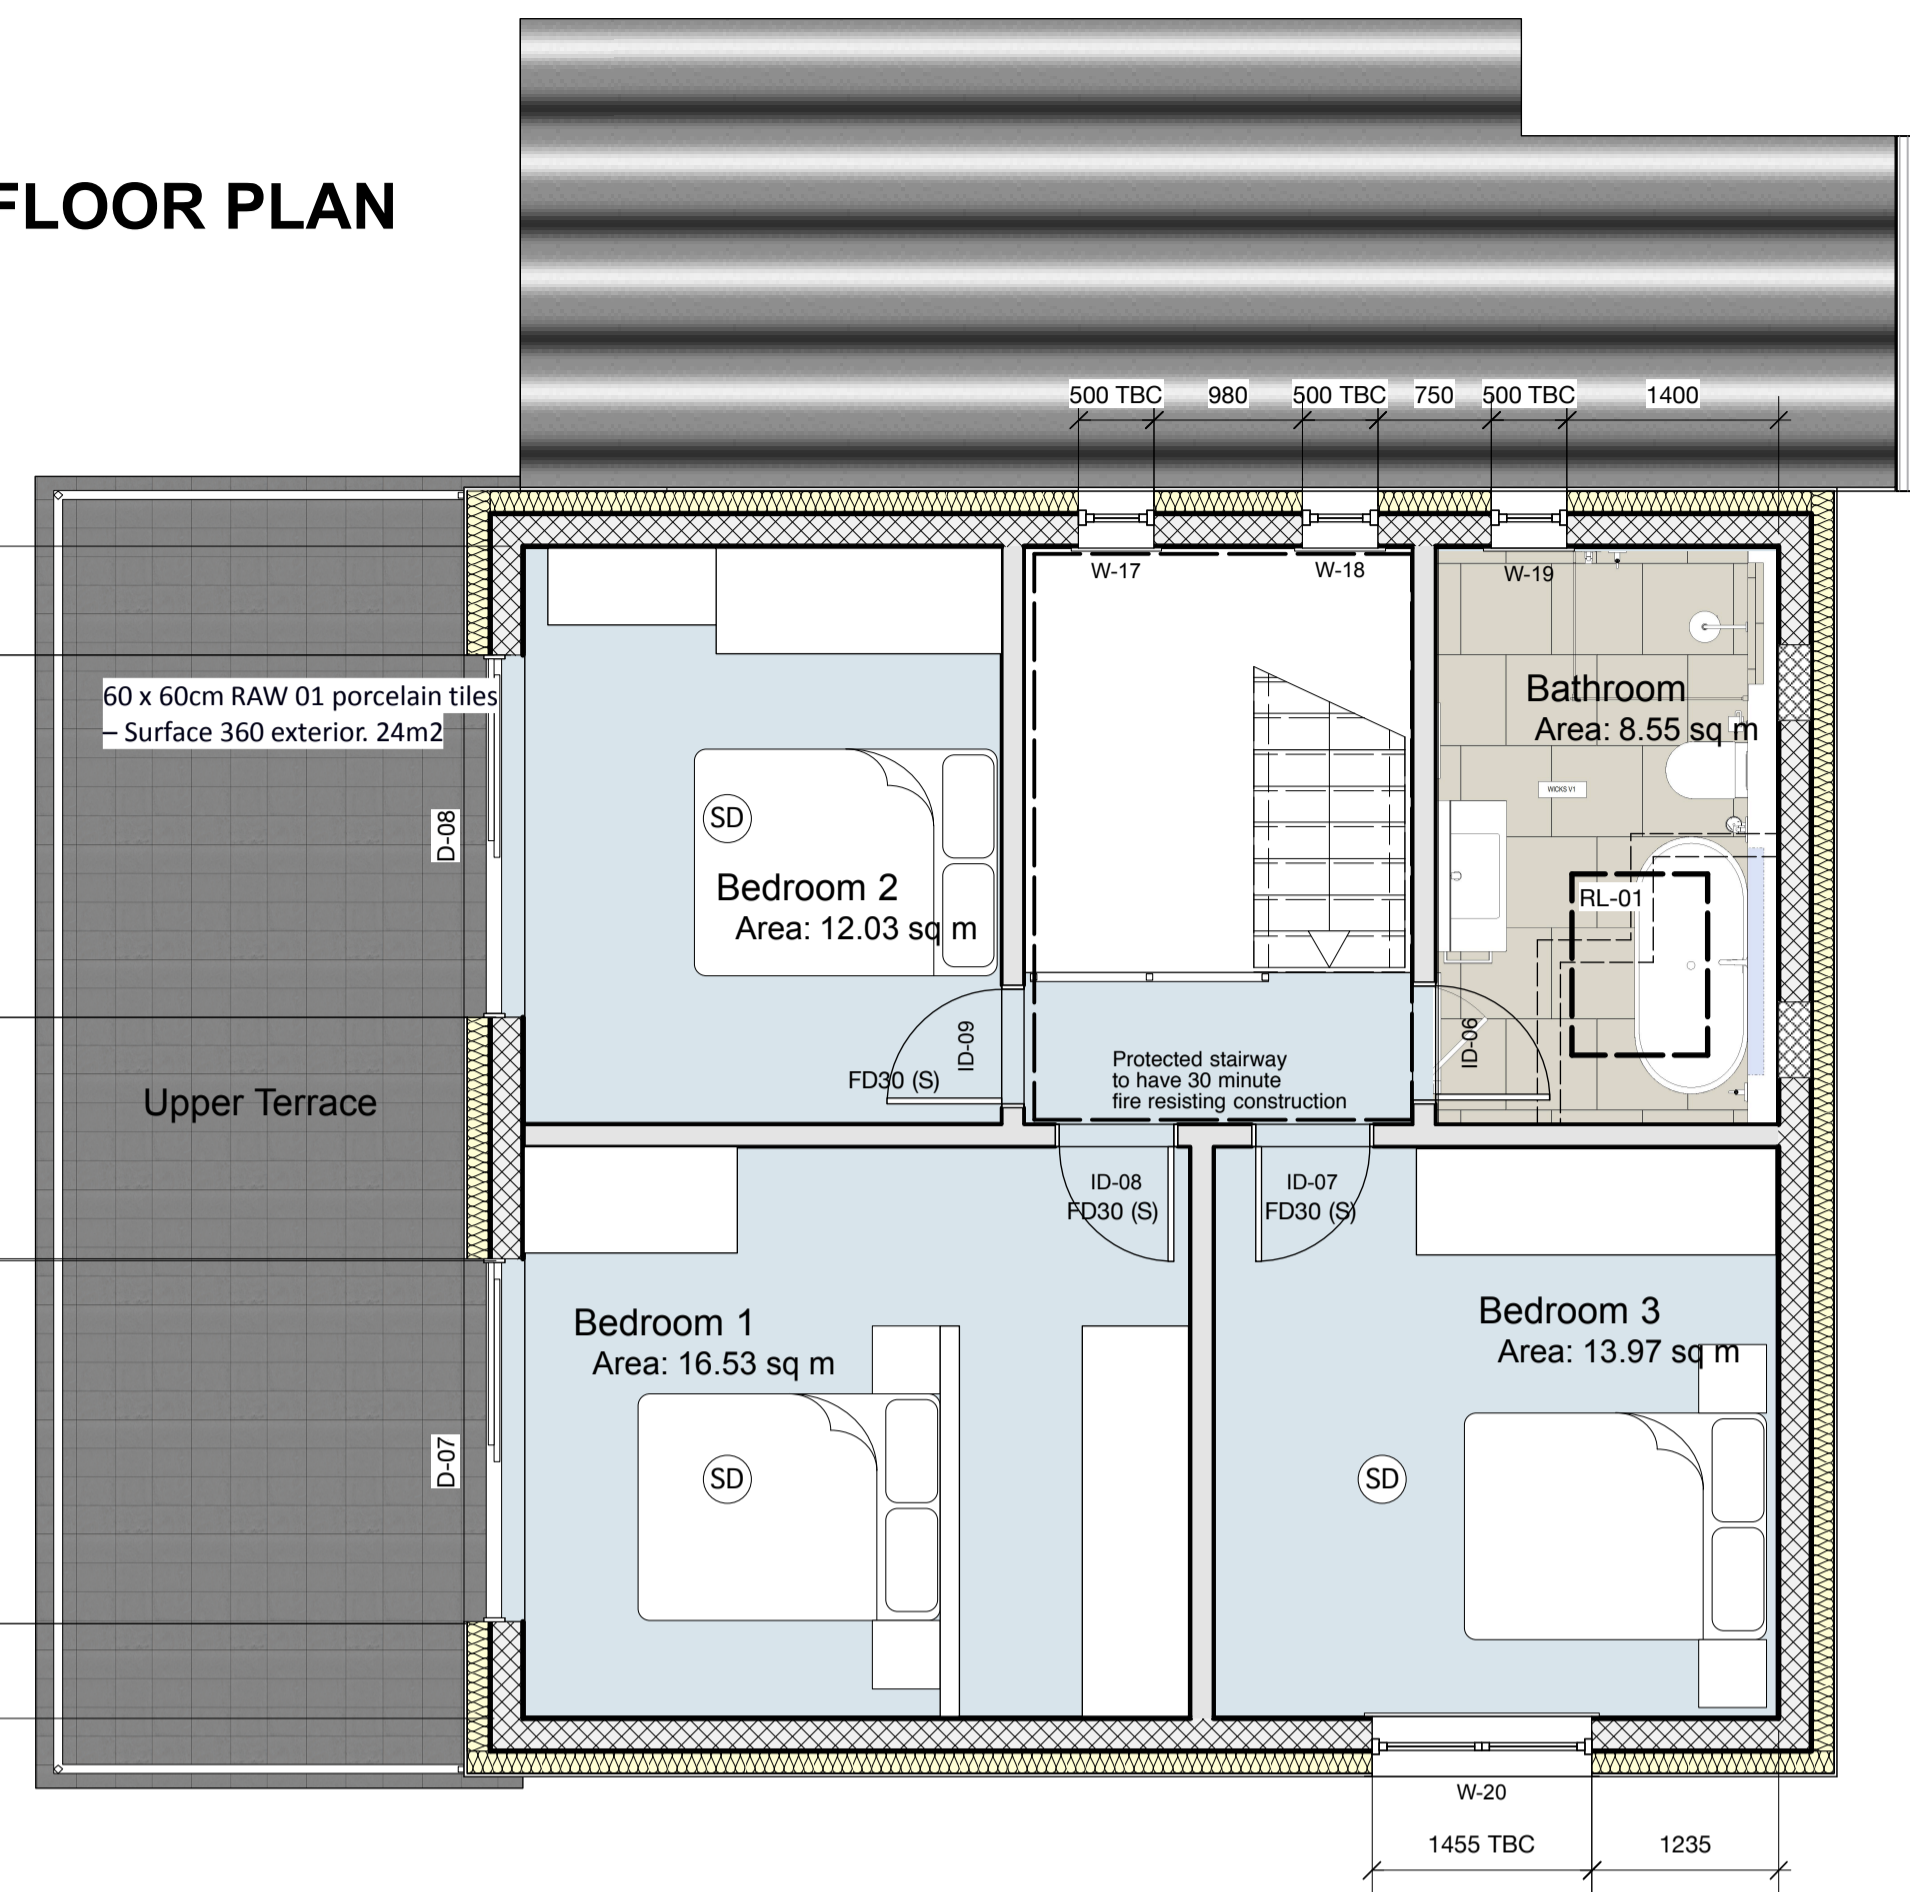




FIRST FLOOR PLAN

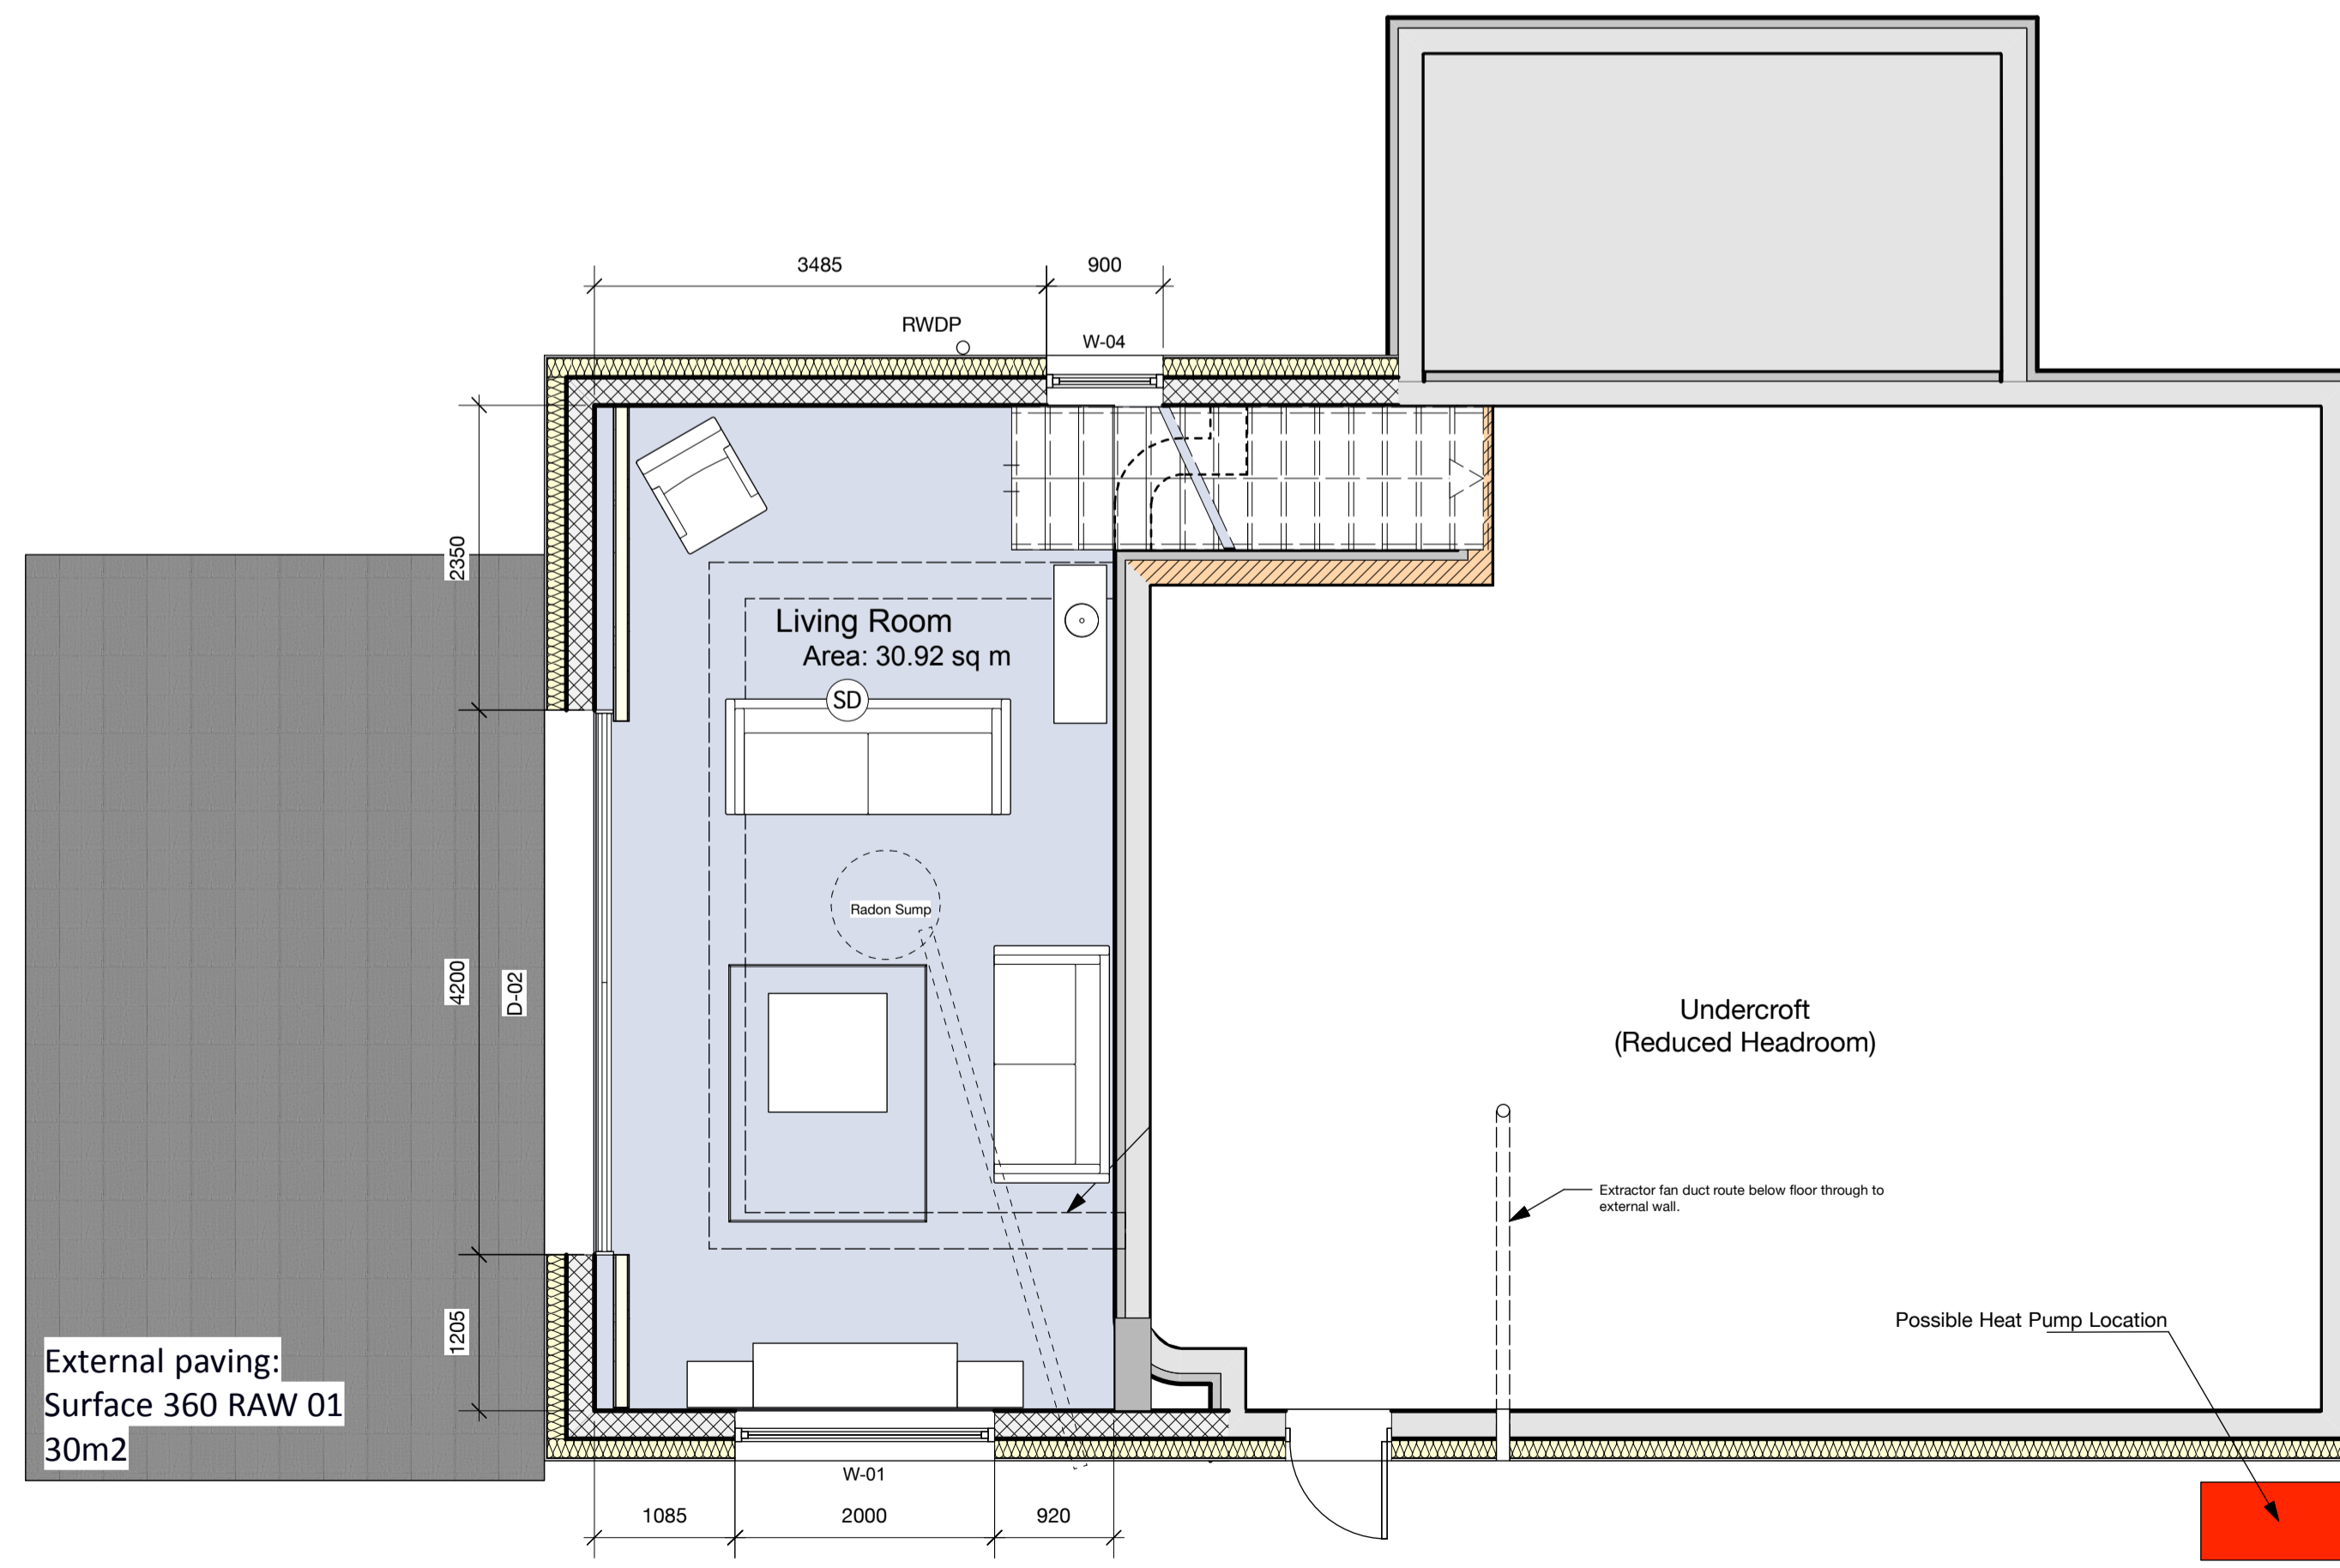

GROUND FLOOR PLAN

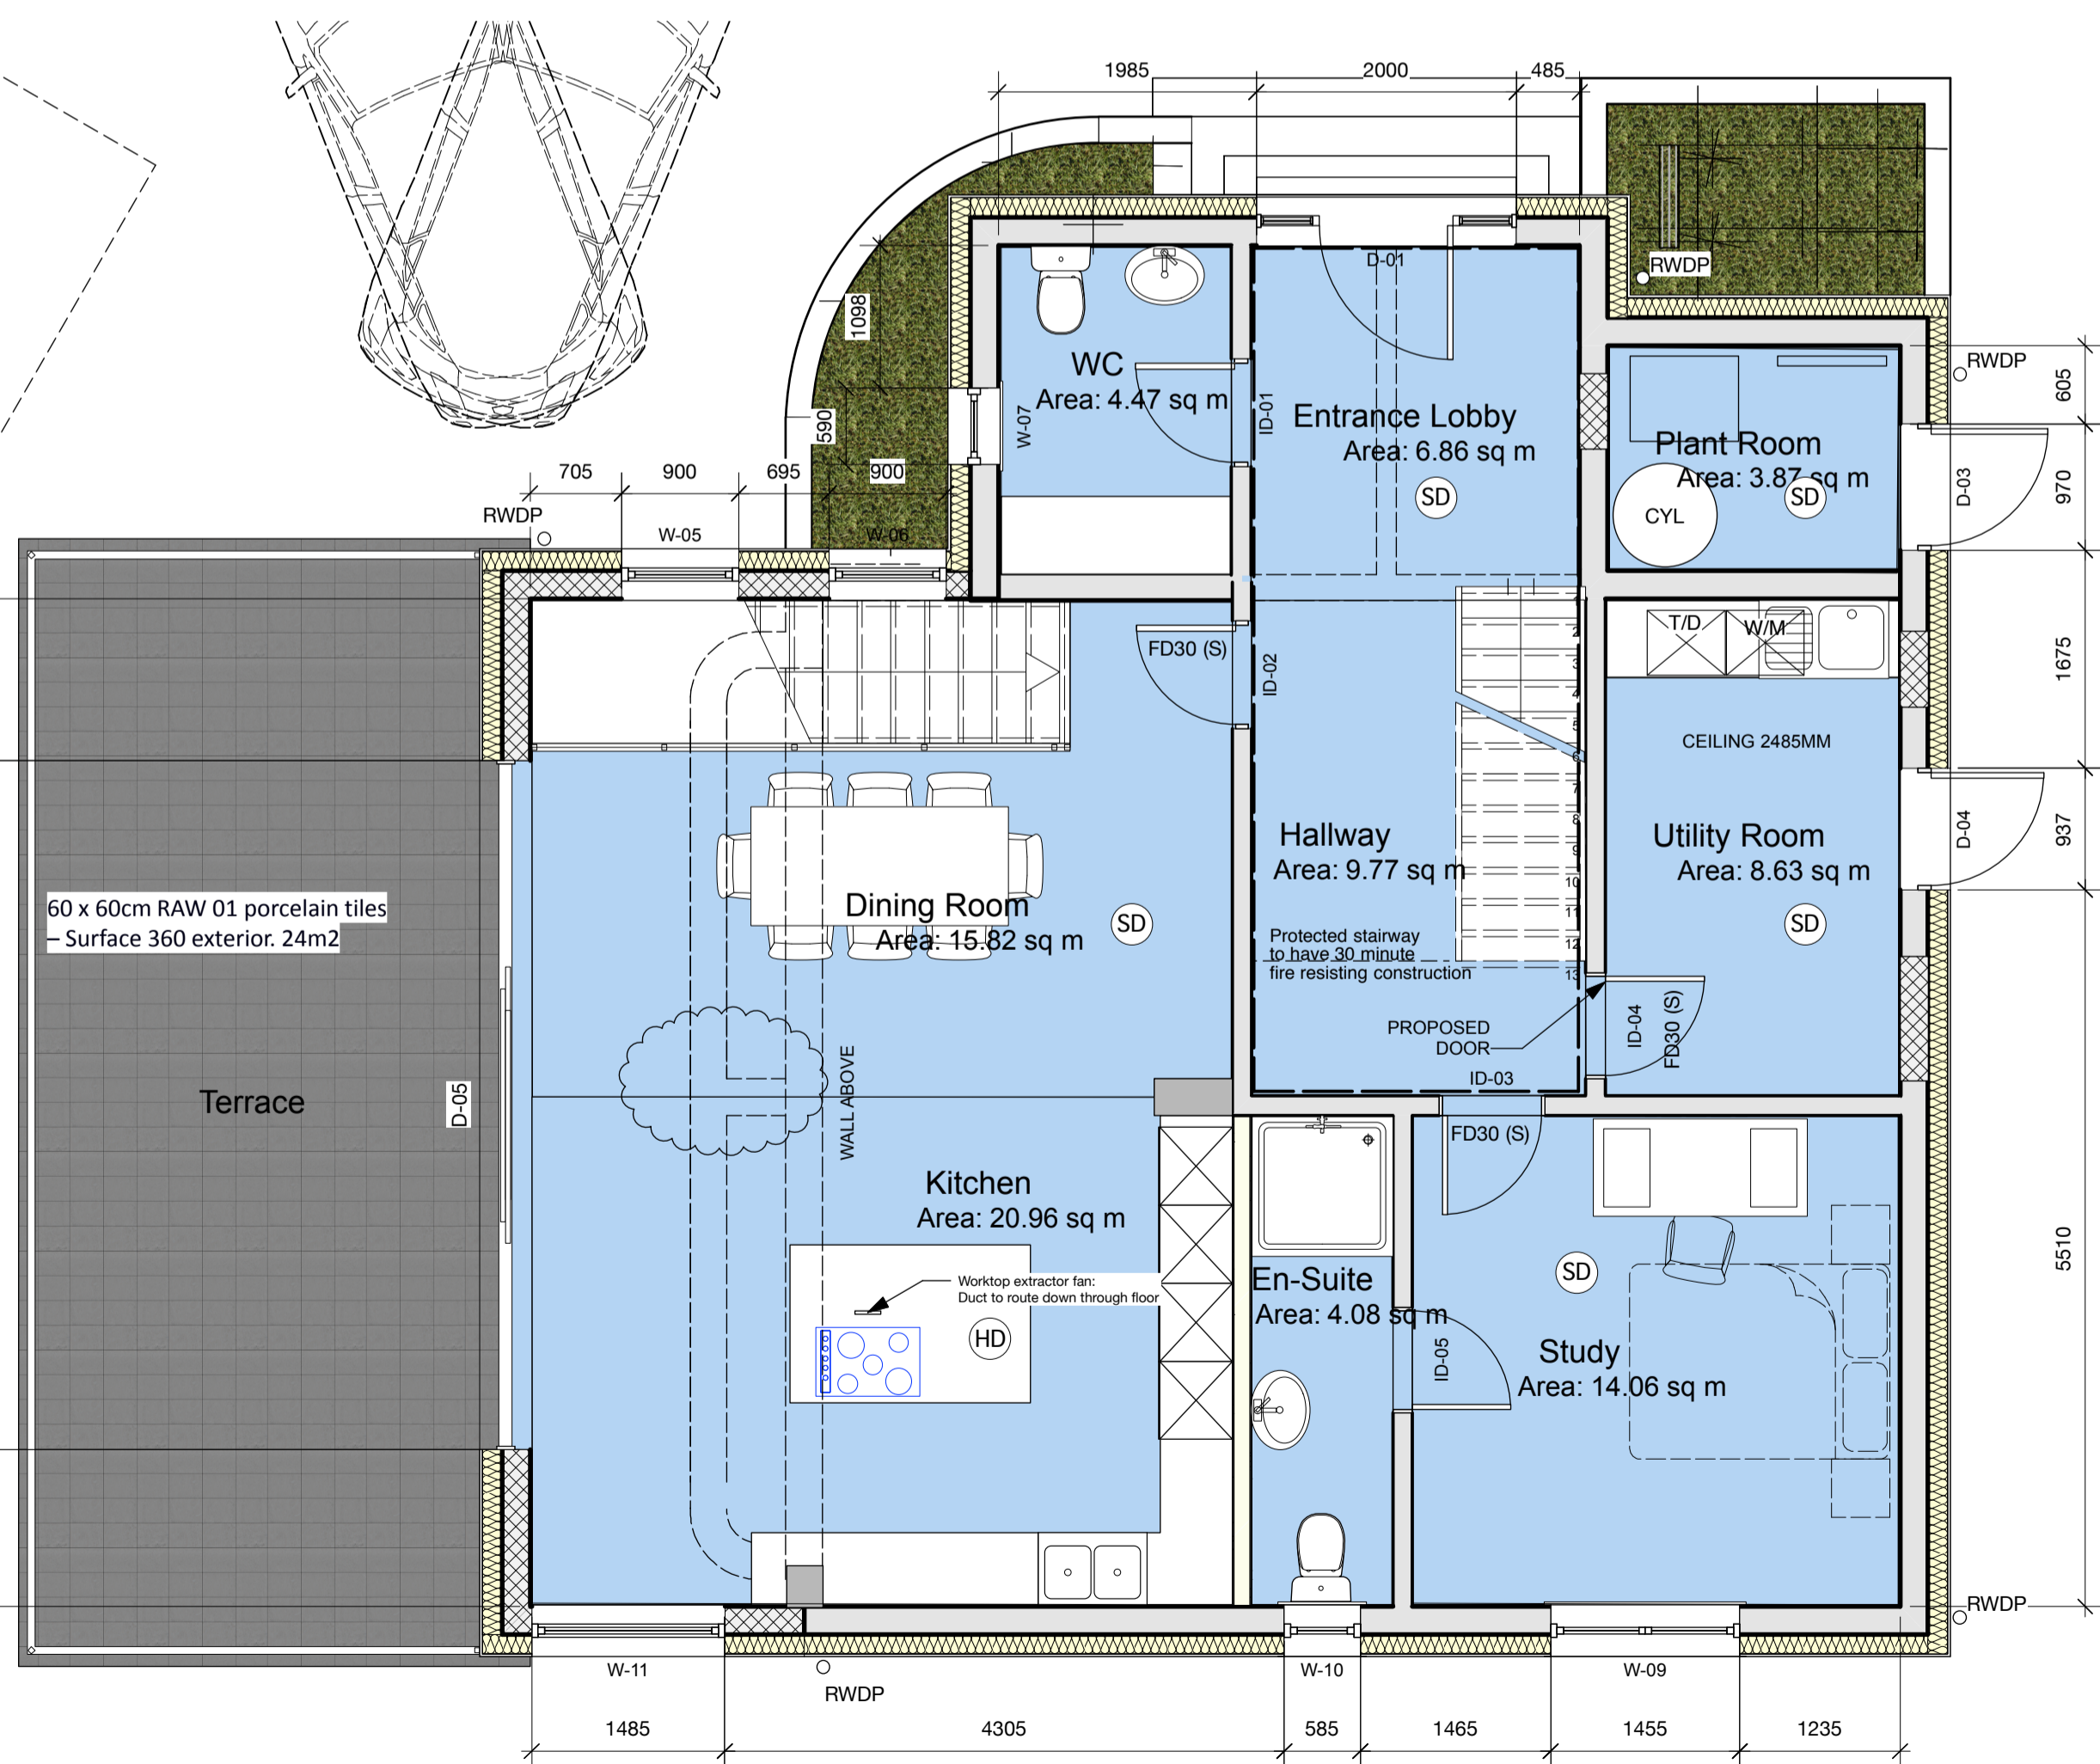

LOWER GROUND FLOOR

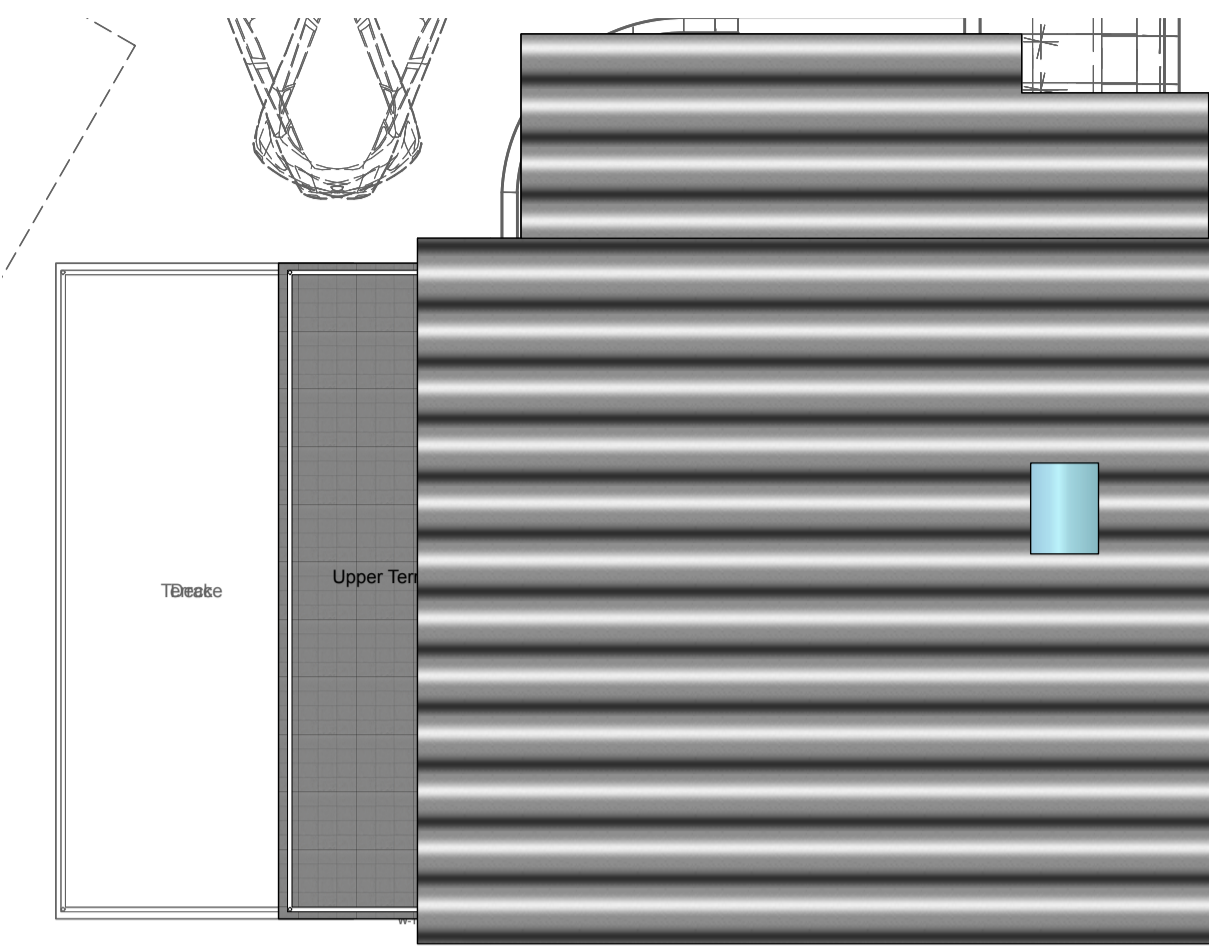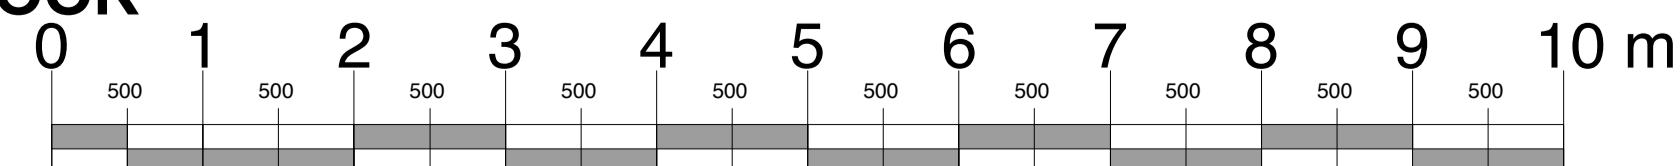

**ROOF PLAN
Scale 1:100**

KEY

- Smoke Detector Fire Alarm
- Heat Detector Fire Alarm
- Carbon Monoxide Detector
- Means of Escape Window / Door

This drawing is **copyright**. Do not scale from this drawing.
All dimensions to be checked on site and any discrepancy, error or omission reported to the architect.
This drawing shall be read in conjunction with all relevant architects' and engineers' drawings and specifications.

File name: 1128 - No.4 White Houses - Construction.vwx

| REV | DRN | CHK | AMENDMENTS | DATE |
|-----|-----|-----|--|------------|
| A | DF | | 1. Remove window W-03. 2. Add RL-03. 3. Center windows & doors with Bedroom 2. | 19/12/18 |
| B | DF | | 1. Change the glazing to the West elevation. | 12/03/18 |
| C | DF | | 1. Remove roof lights for Hallway. | 19/03/18 |
| D | DF | | Construction Issue | 24.07.2019 |
| E | DF | | Construction: 1. Remove Window No. W-08 from Utility Room. | 25.07.2019 |
| F | DF | | Construction: 1. Confirm no pier at ground floor level between Kitchen and Dining Areas. As per Engineers design. | 25.07.2019 |

PROJECT
4 WHITE HOUSES
NOIRMONT LANE
ST. BRELADE
JERSEY

CLIENT
Mr. A & Mrs. J Wicks

DRAWING
PROPOSED
FLOOR PLANS

SCALE
1:50 at A1

DRAWN
D.F

CHECKED
.

STATUS
Construction



13 Royal Square, St. Helier, JE2 4WA
T : 01534 73310
E : mail@a-bcf.com www.a-bcf.com

DRAWING No
1128.07

REVISION
F